


[illegible]


Paper Size	ISO A1
------------	--------

Ox Existing Oxygen Terminal
 OX New Oxygen Wall Outlet Terminal
 Vac New Vacuum Wall Outlet Terminal
 Ae Existing Medical Air Terminal
 R New Medical Air Wall Outlet Terminal

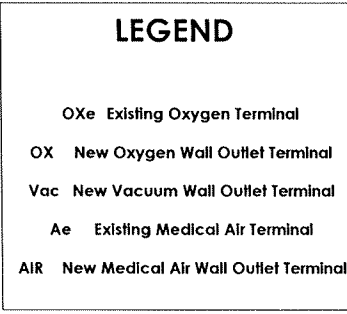

$P_{\text{tot}} \approx 50.40 \text{ KW}$ $P_{\text{max}} \approx 45.36 \text{ KW}$ $S_{\text{max}} \approx 53.36 \text{ KVA}$
 $\text{df} = 0.90$ $\text{pf} = 0.85$

Project No.	Paper Size
-------------	------------

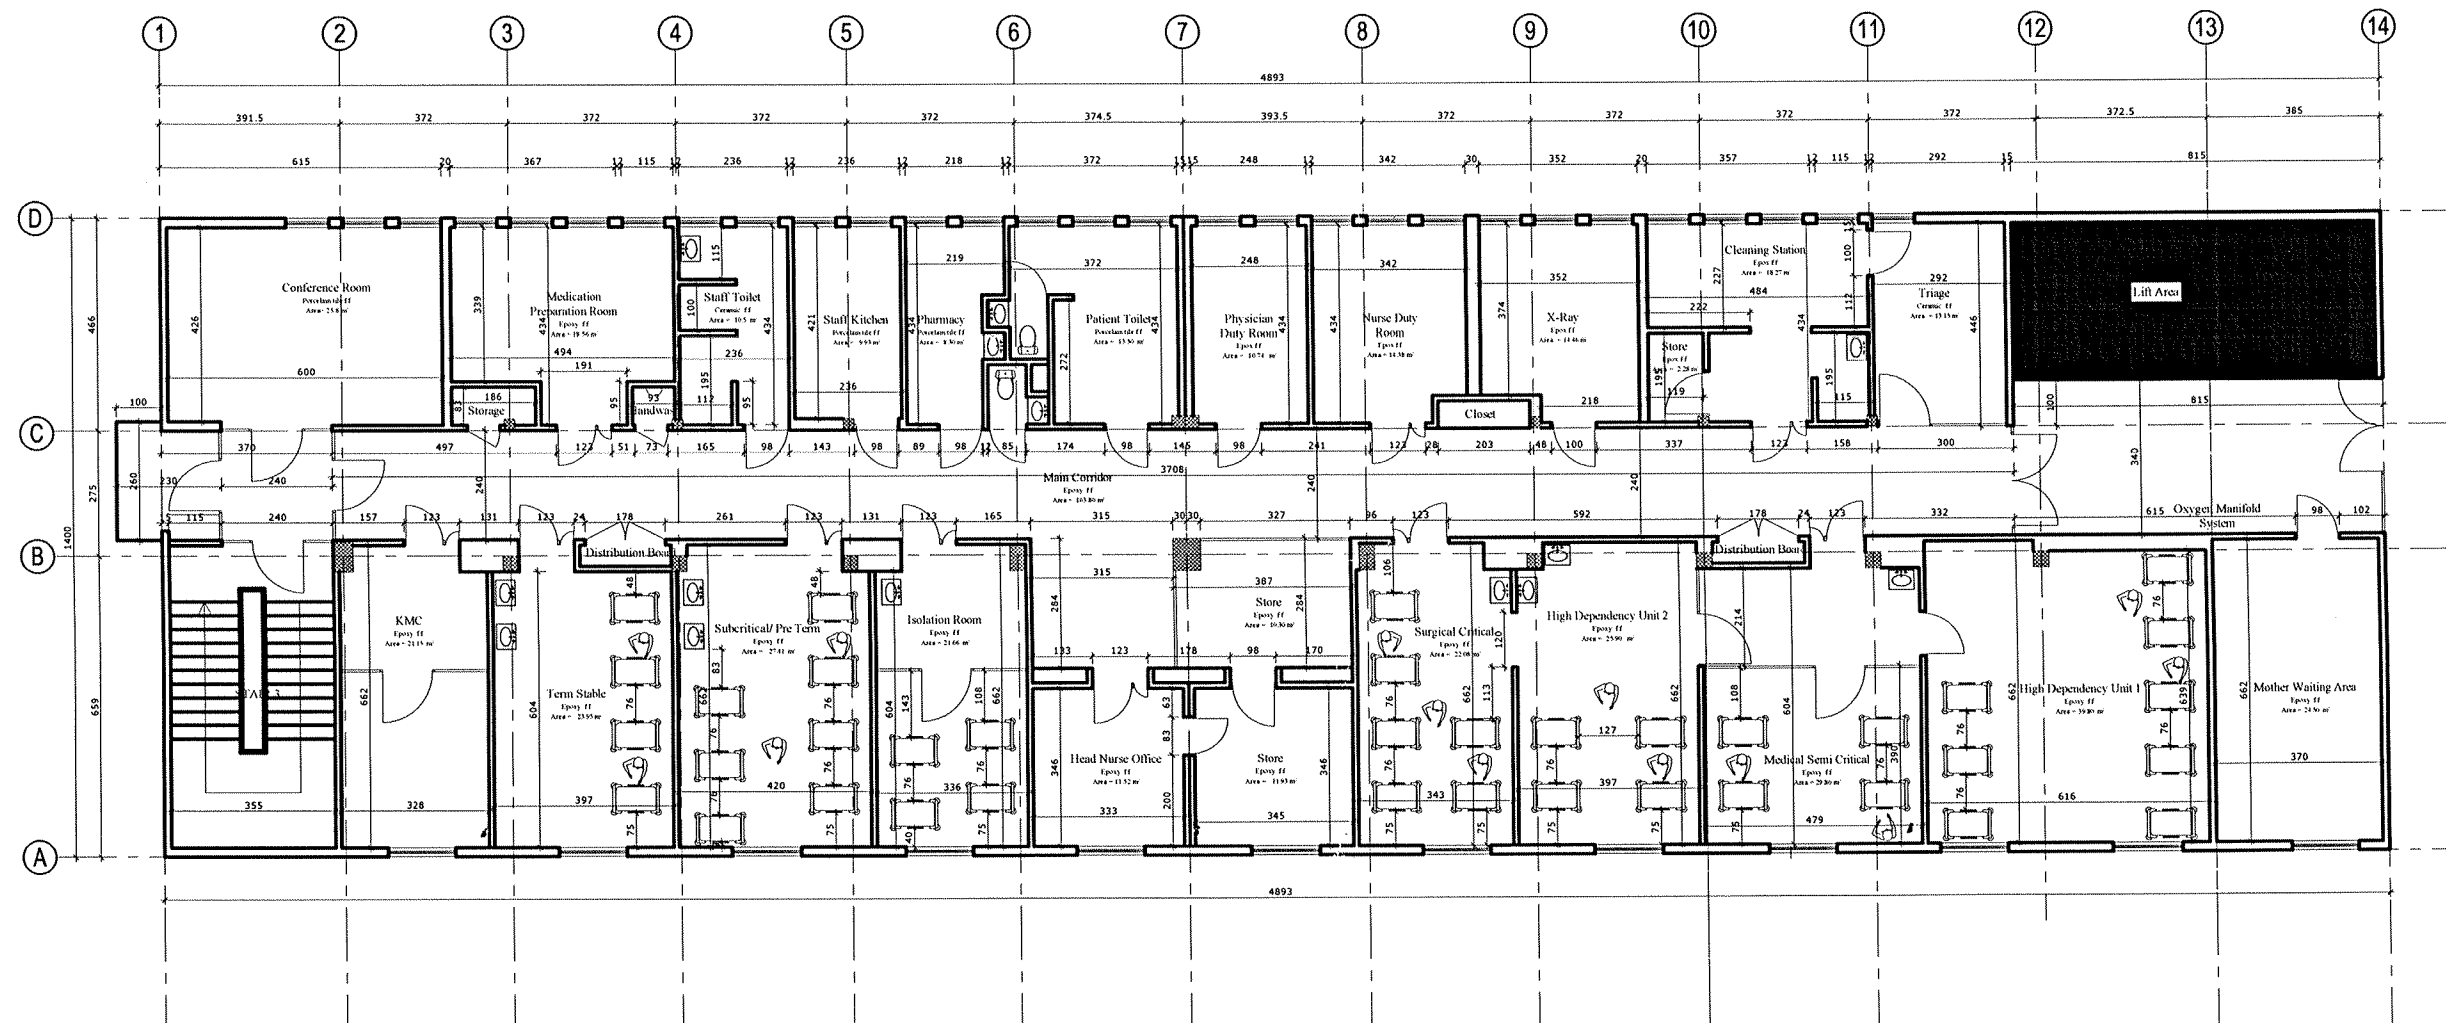

NICU Floor Plan Scale 1:80

GENERAL NOTES

No. REVISION / ISSUE DATE

ARCHITECTURAL DESIGN

Project Name
**Black Lion NICU
Rehabilitation**

Project Address
Location:
Sub city: Kebele / Wereda:
Parcel No.: House No.:
Title Deed no.:

Project Owner
DOCTORS WITH AFRICA - CUAMM

Drawing Title
Black Lion NICU Floor Plan

Project Status
☐ New ☐ Modification ☐ As Built

Designed By
Solomon Tesfay

Drawn By
Staff

Checked By

Scale
1:80

Date
Nov-2024

Project No.

Drawing No.
**AR
01/01**

Paper Size
ISO A1